


1/10/2012 4:38:51 PM T:\projects\GREEN LAKE\16 CAMP GROUND SEWER AND WATERS SERVICES\POWER\CIVIL DESIGN\2010\_08\_22\PRELIM.dwg

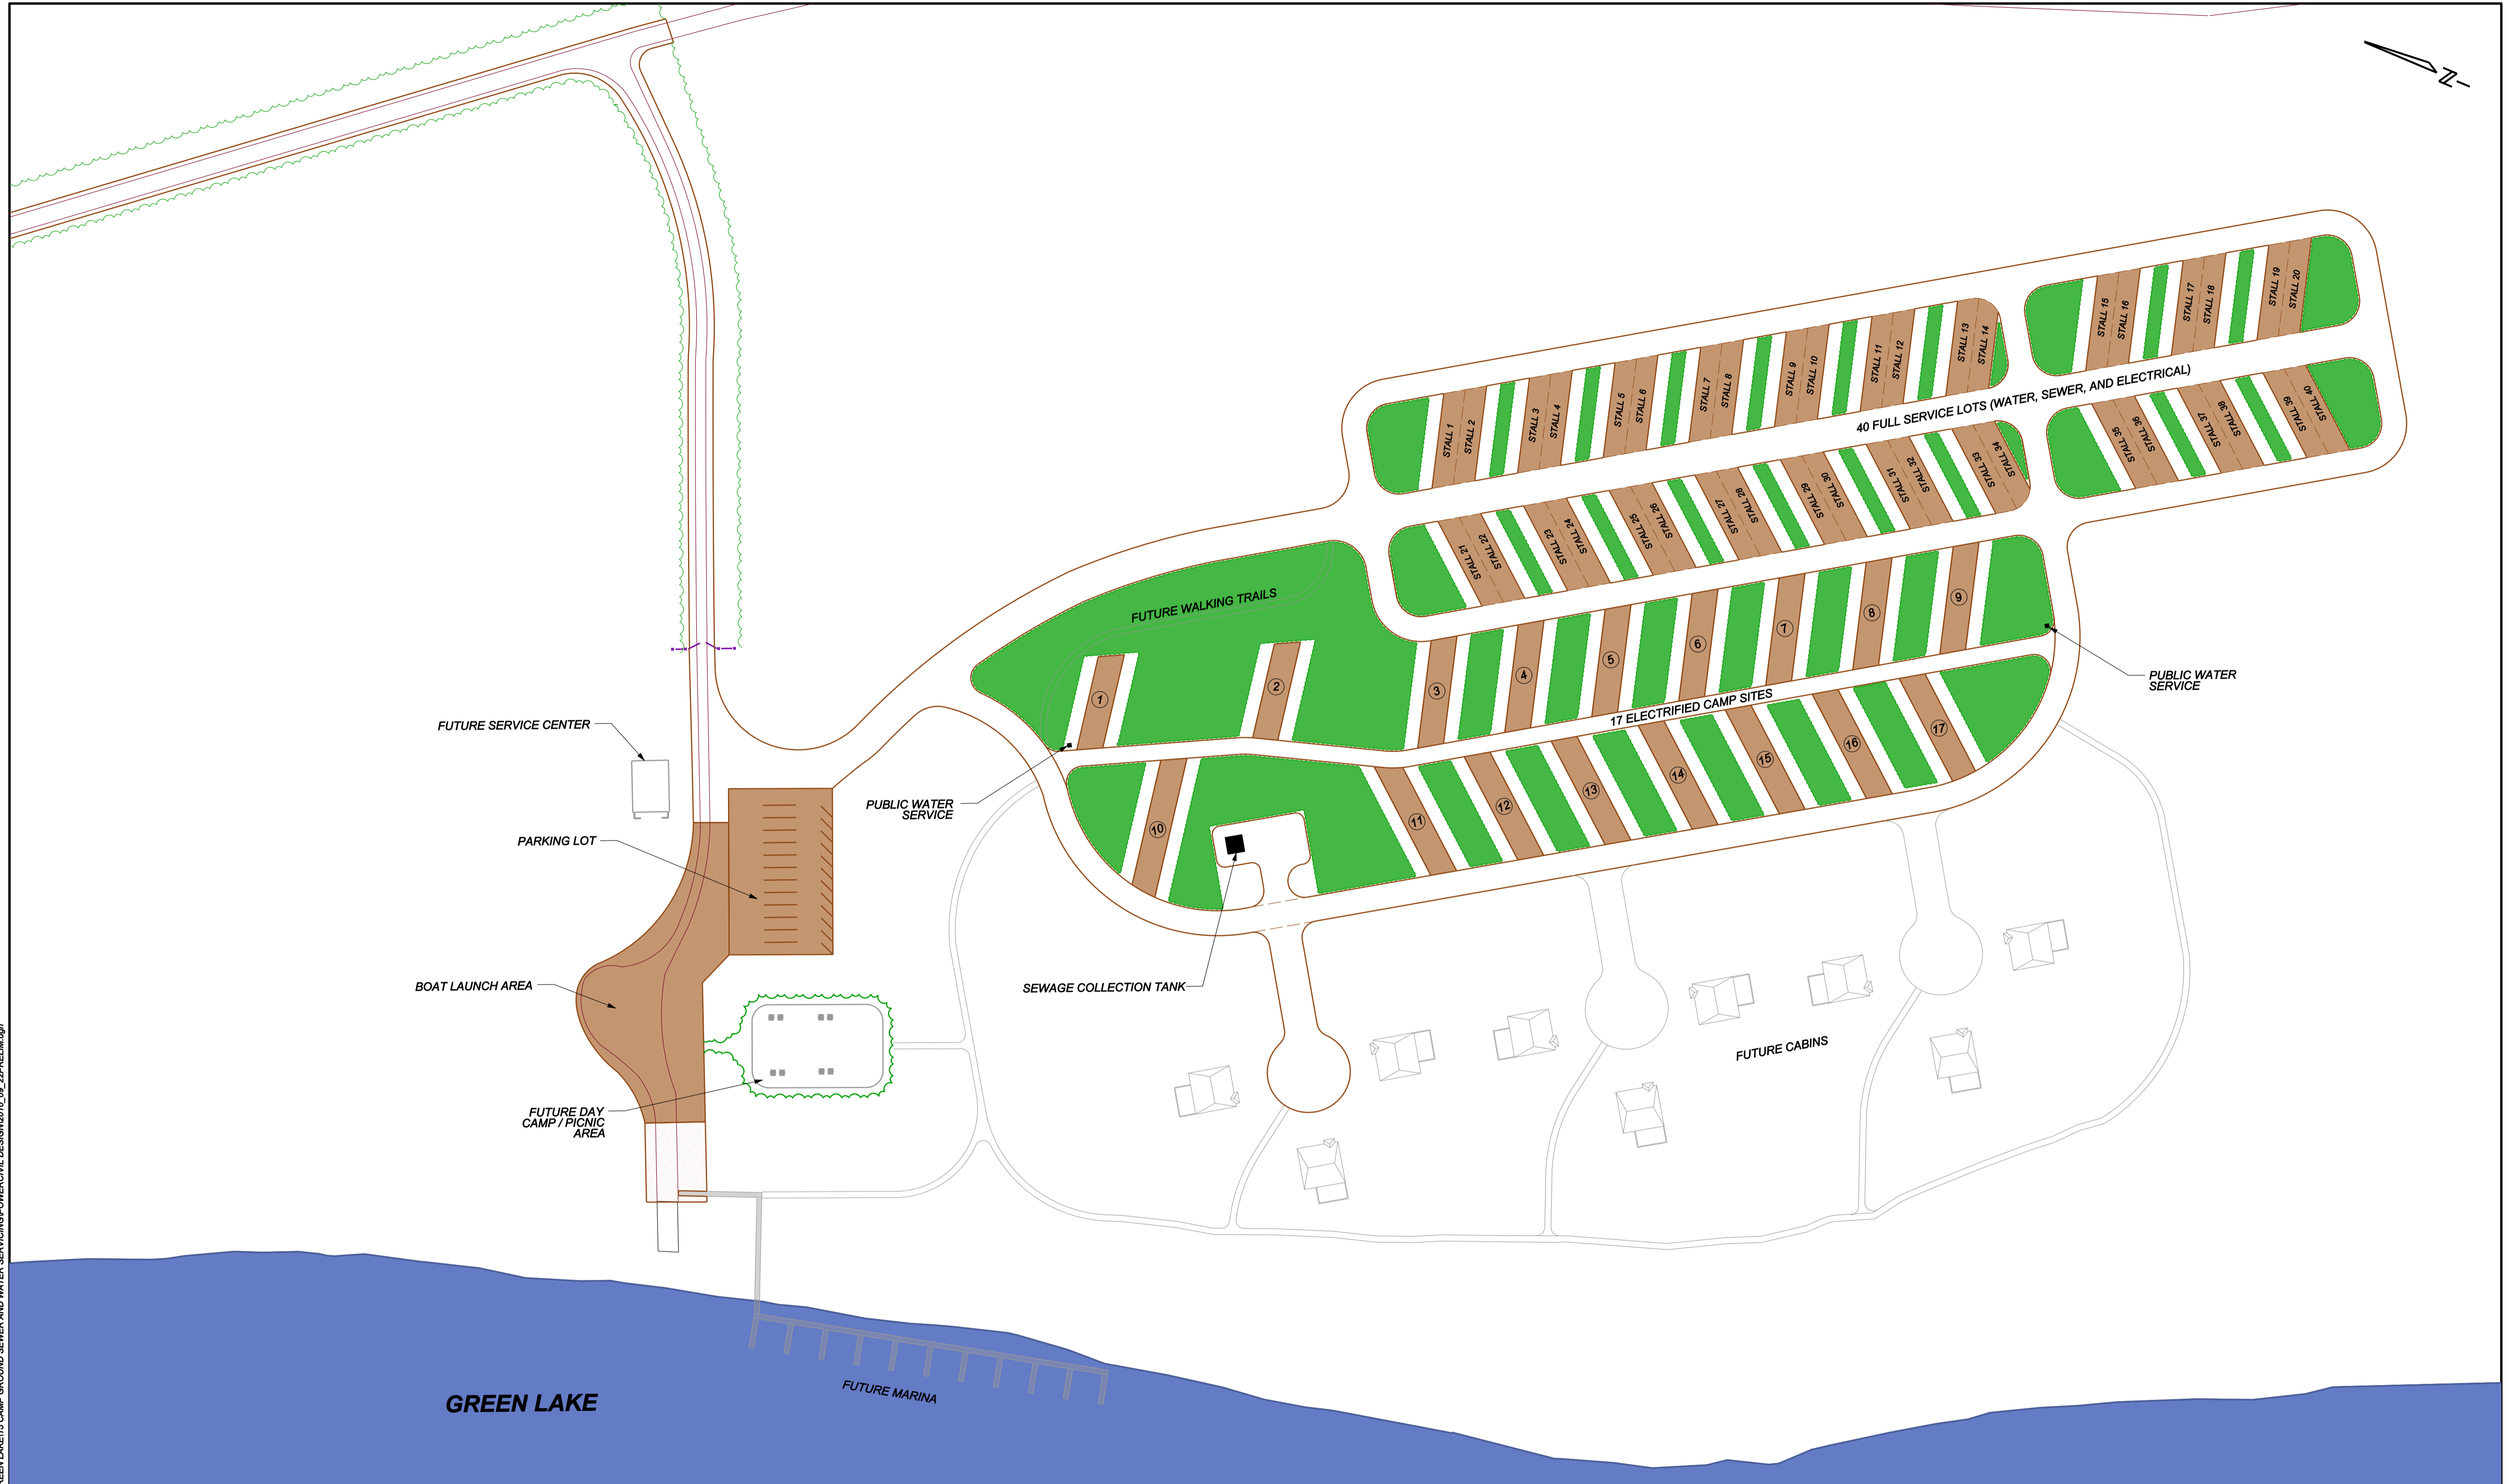

**NORTHERN VILLAGE OF GREEN LAKE**

**PROPOSED  
R.V. PARK AND RECREATION SITE  
SITE PLAN**

SCALE 1:750  
DATE JAN.2012  
JOB No. 67.15

DRAWING No.

**1**

DRAWN: D.J.R. CHECKED: T.J.M. DESIGNED: K.J.T. REVISION:

SHEET 1 OF 1